

WILLOWDALE PARK RESTROOM BUILDING TOWN OF AMHERST

750 N FOREST RD
AMHERST, NY 14221

PROJECT NO. 2025.024A
PUD APPROVAL SUBMISSION

JULY 24, 2026



TOWN ATTORNEY
STEVE BENGART


TOWN ENGINEER
JEFFREY BURROUGHS

SUPERINTENDENT OF HIGHWAYS
STEVEN FLOSS



DiDONATO Project No. 26-2720

CONSULTANTS

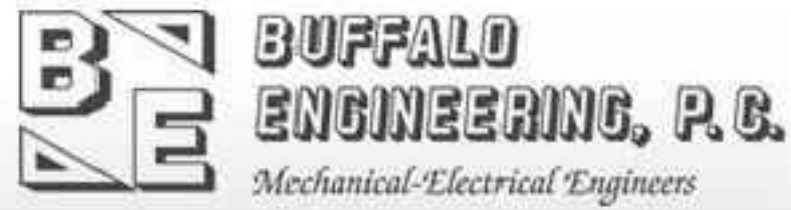

TOWN SUPERVISOR
SHAWN LAVIN

TOWN COUNCILMEMBERS
MICHAEL SZUKALA
ANGELA MARINUCCI
JOHN DAVIS
JACK KAVANAUGH

TOWN CLERK
FANCINA J. SPOTH



PUD Submission Only

DRAWING INDEX


ARCHITECTURAL

A-101 FLOOR PLAN
A-201 ELEVATIONS

ELECTRICAL

ES-101 ELECTRICAL SITE PHOTOMETRIC PLAN
ES-102 ELEVATIONS - ELECTRICAL

PROJECT
LOCATION

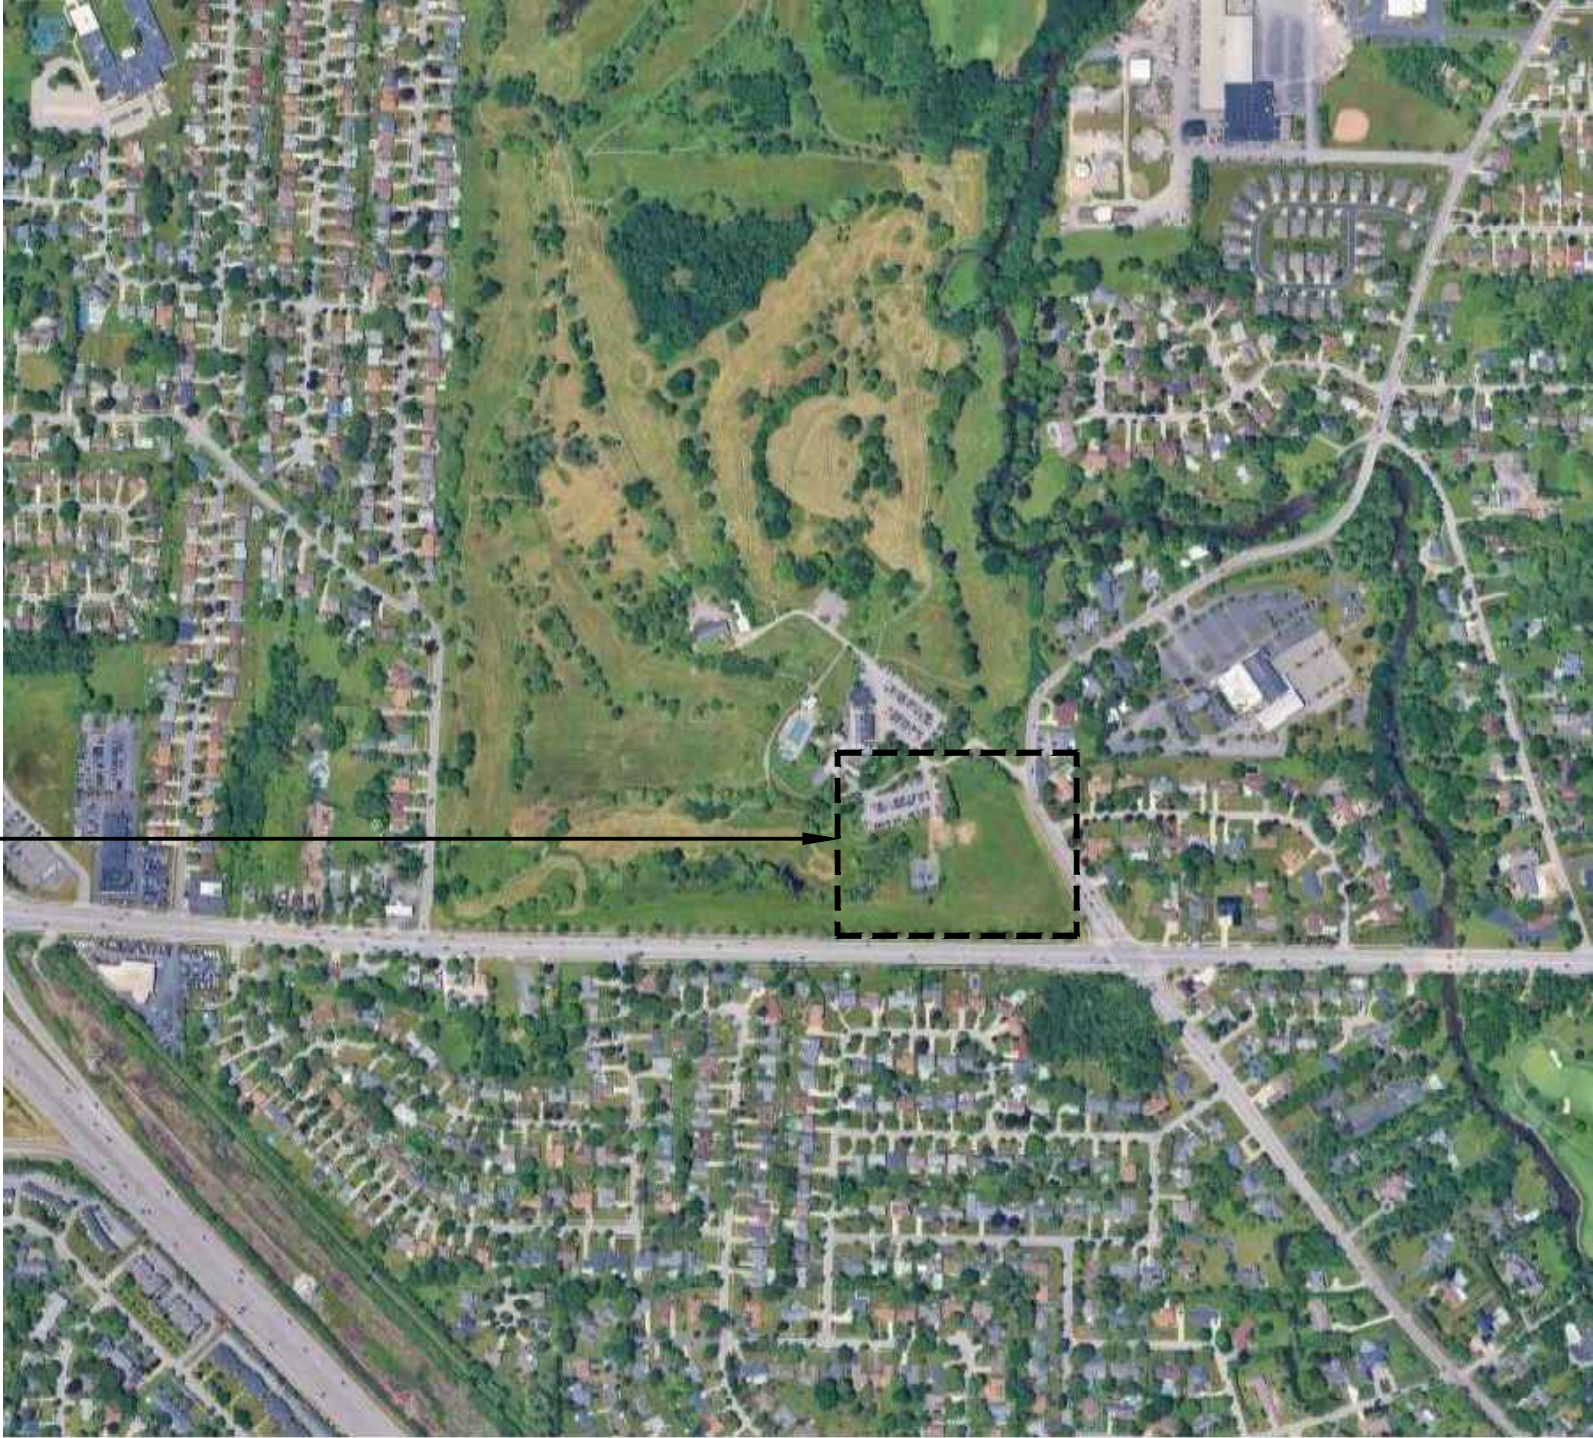

LOCATION MAP





TOWN OF AMHERST
WILLOWDALE PARK
RESTROOM BUILDING

PUD Submission Only


1	7/24/2026	PUD SUBMISSION
MARK	DATE	DESCRIPTION
ISSUE:		
PROJECT NO:		2025.024A
DESIGNER PROJECT NO:		26-3720
CAD DWG FILE:		A-201.dwg
DRAWN BY:		DJM
CHECKED BY:		MWB
SCALE:		AS NOTED
COPYRIGHT:		

SHEET TITLE


EXTERIOR ELEVATIONS

DRAWING#


A-201

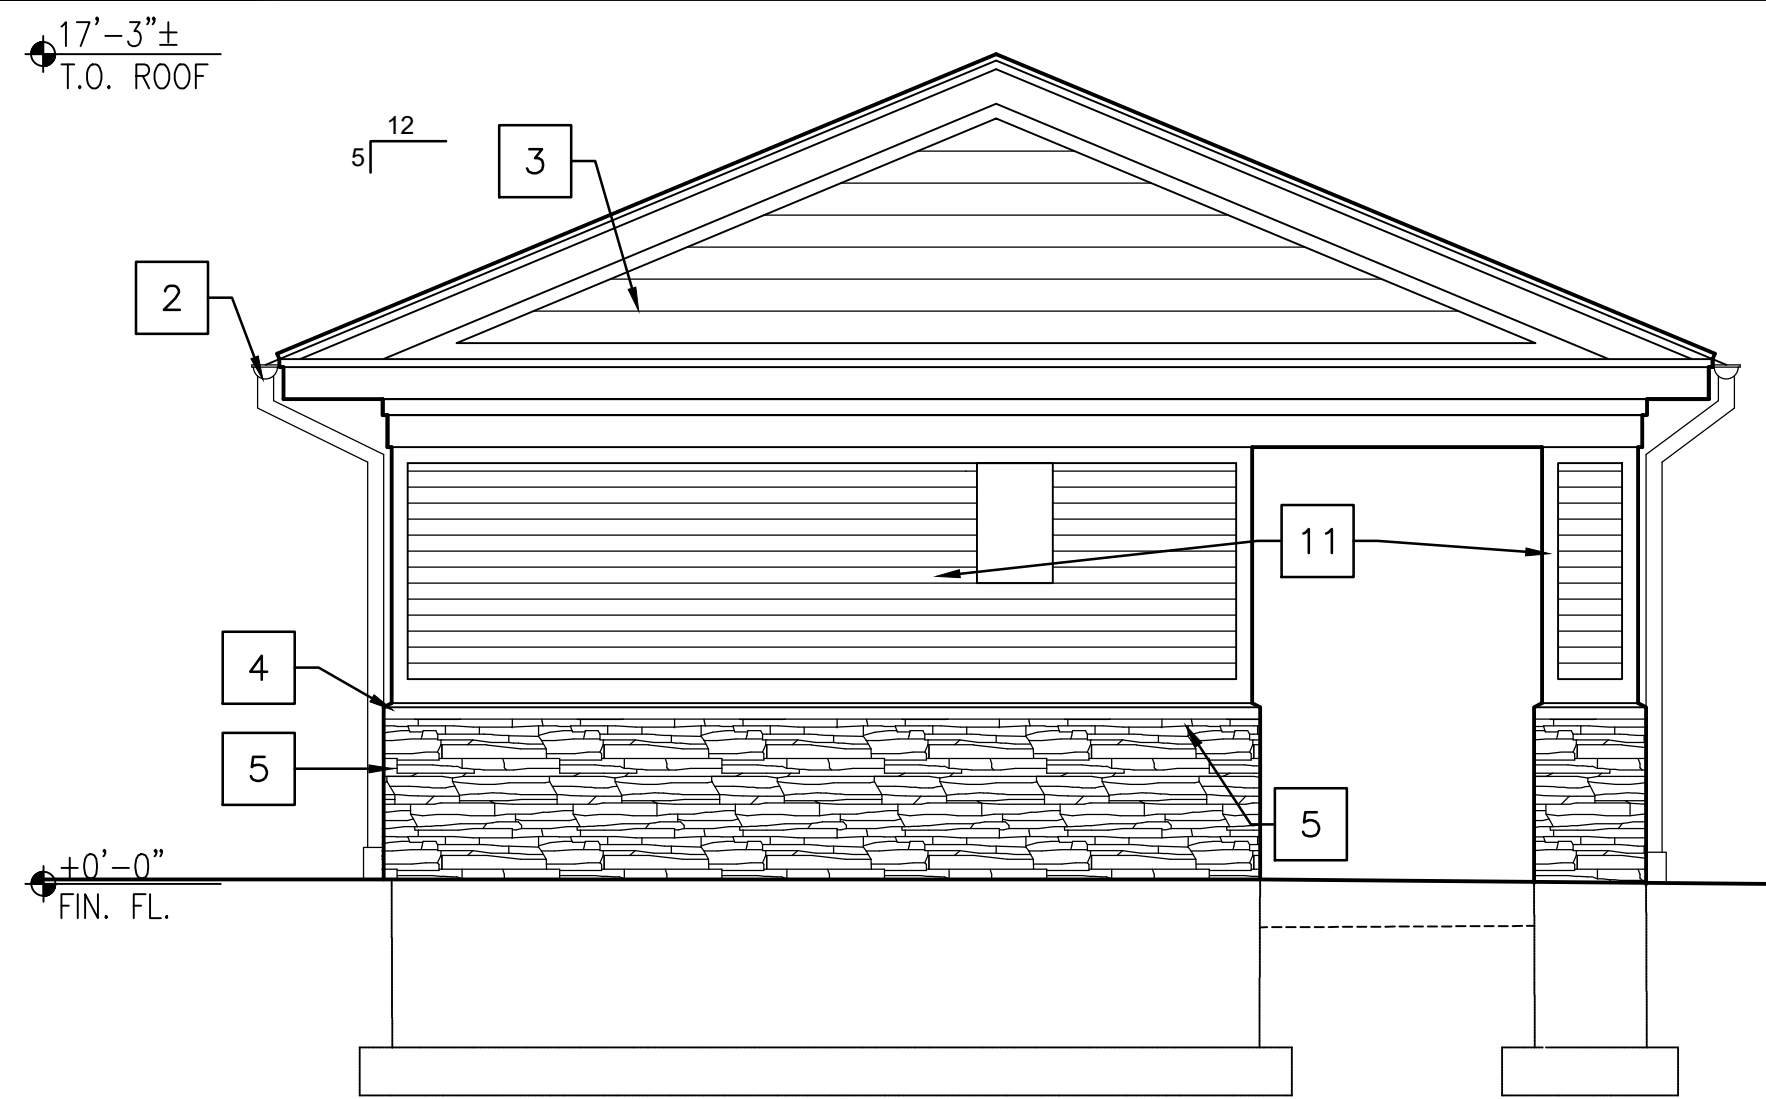


D1 **ELEVATION**
SCALE: 1/4" = 1'-0"

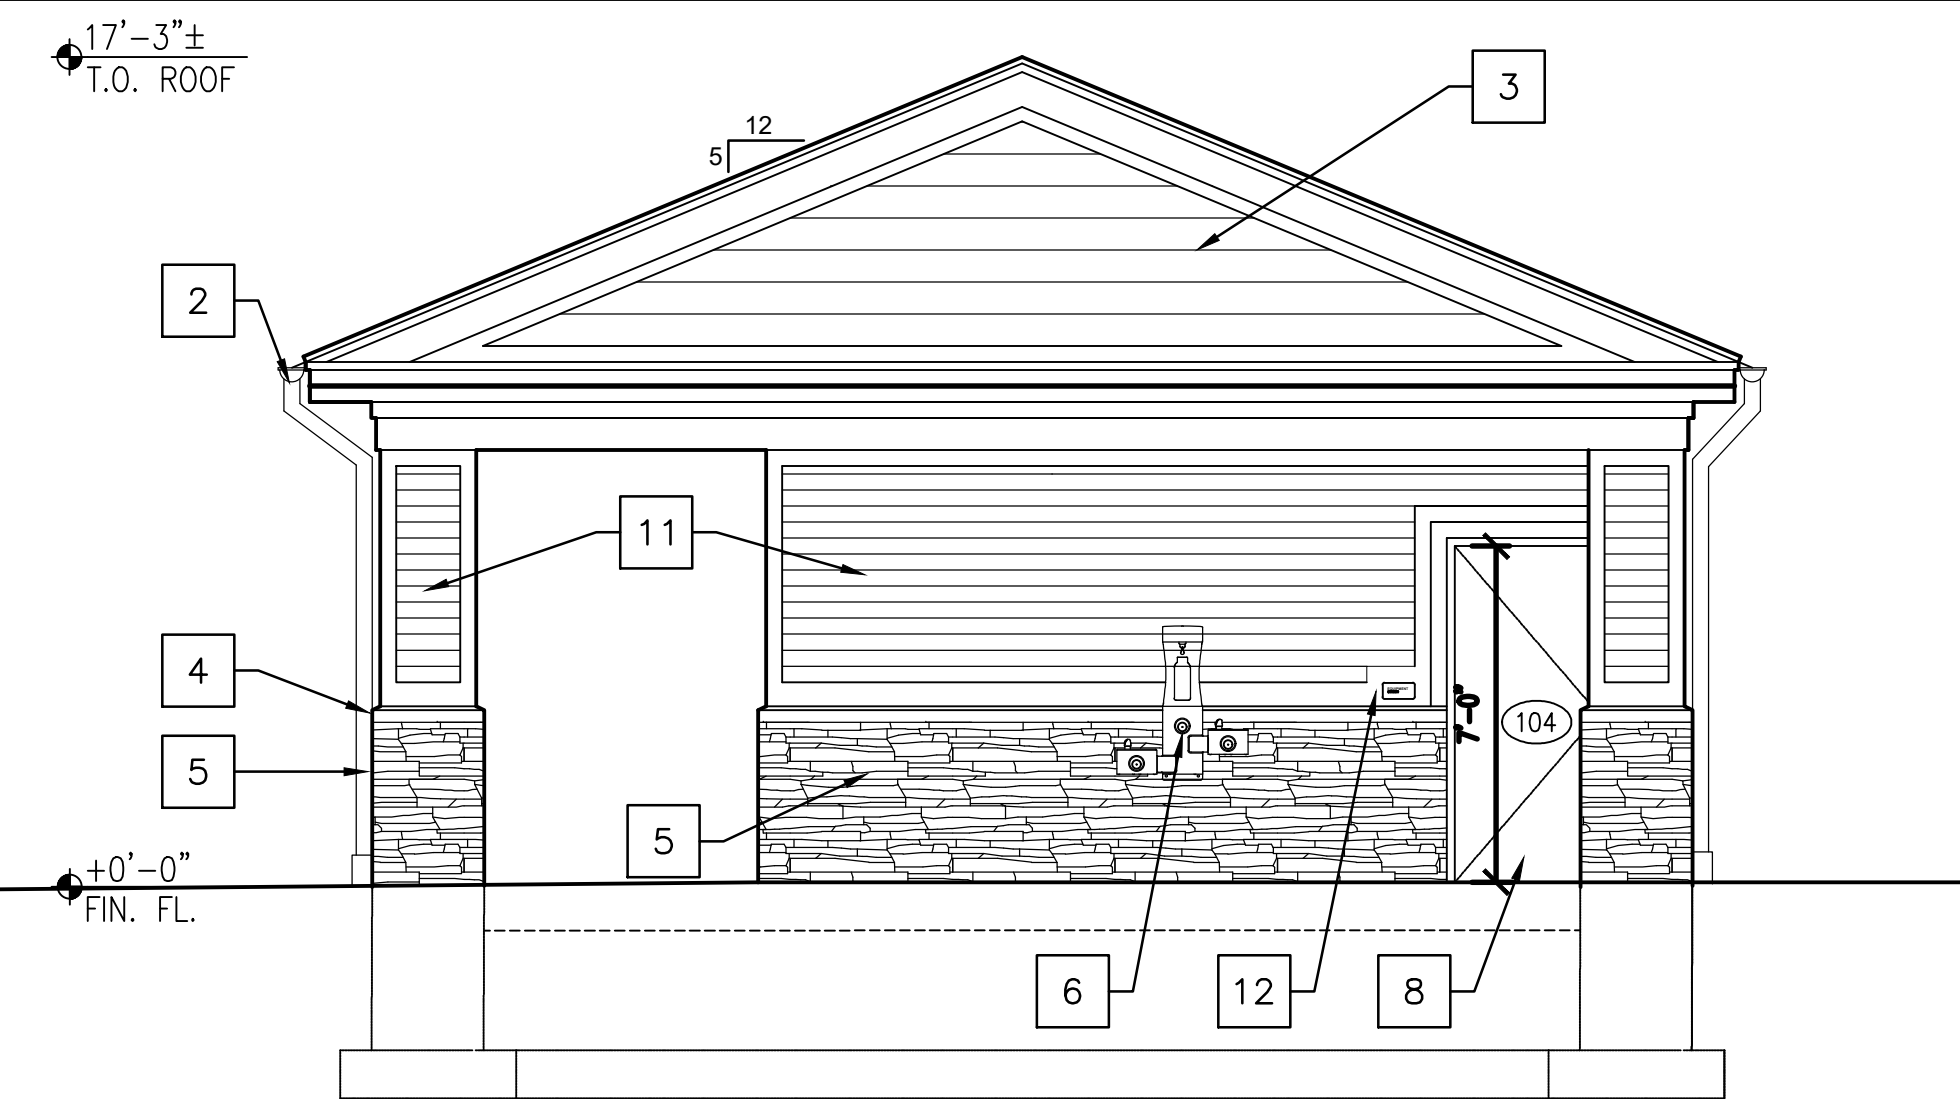

D5 ELEVATION
SCALE: 1/4" = 1'-0"

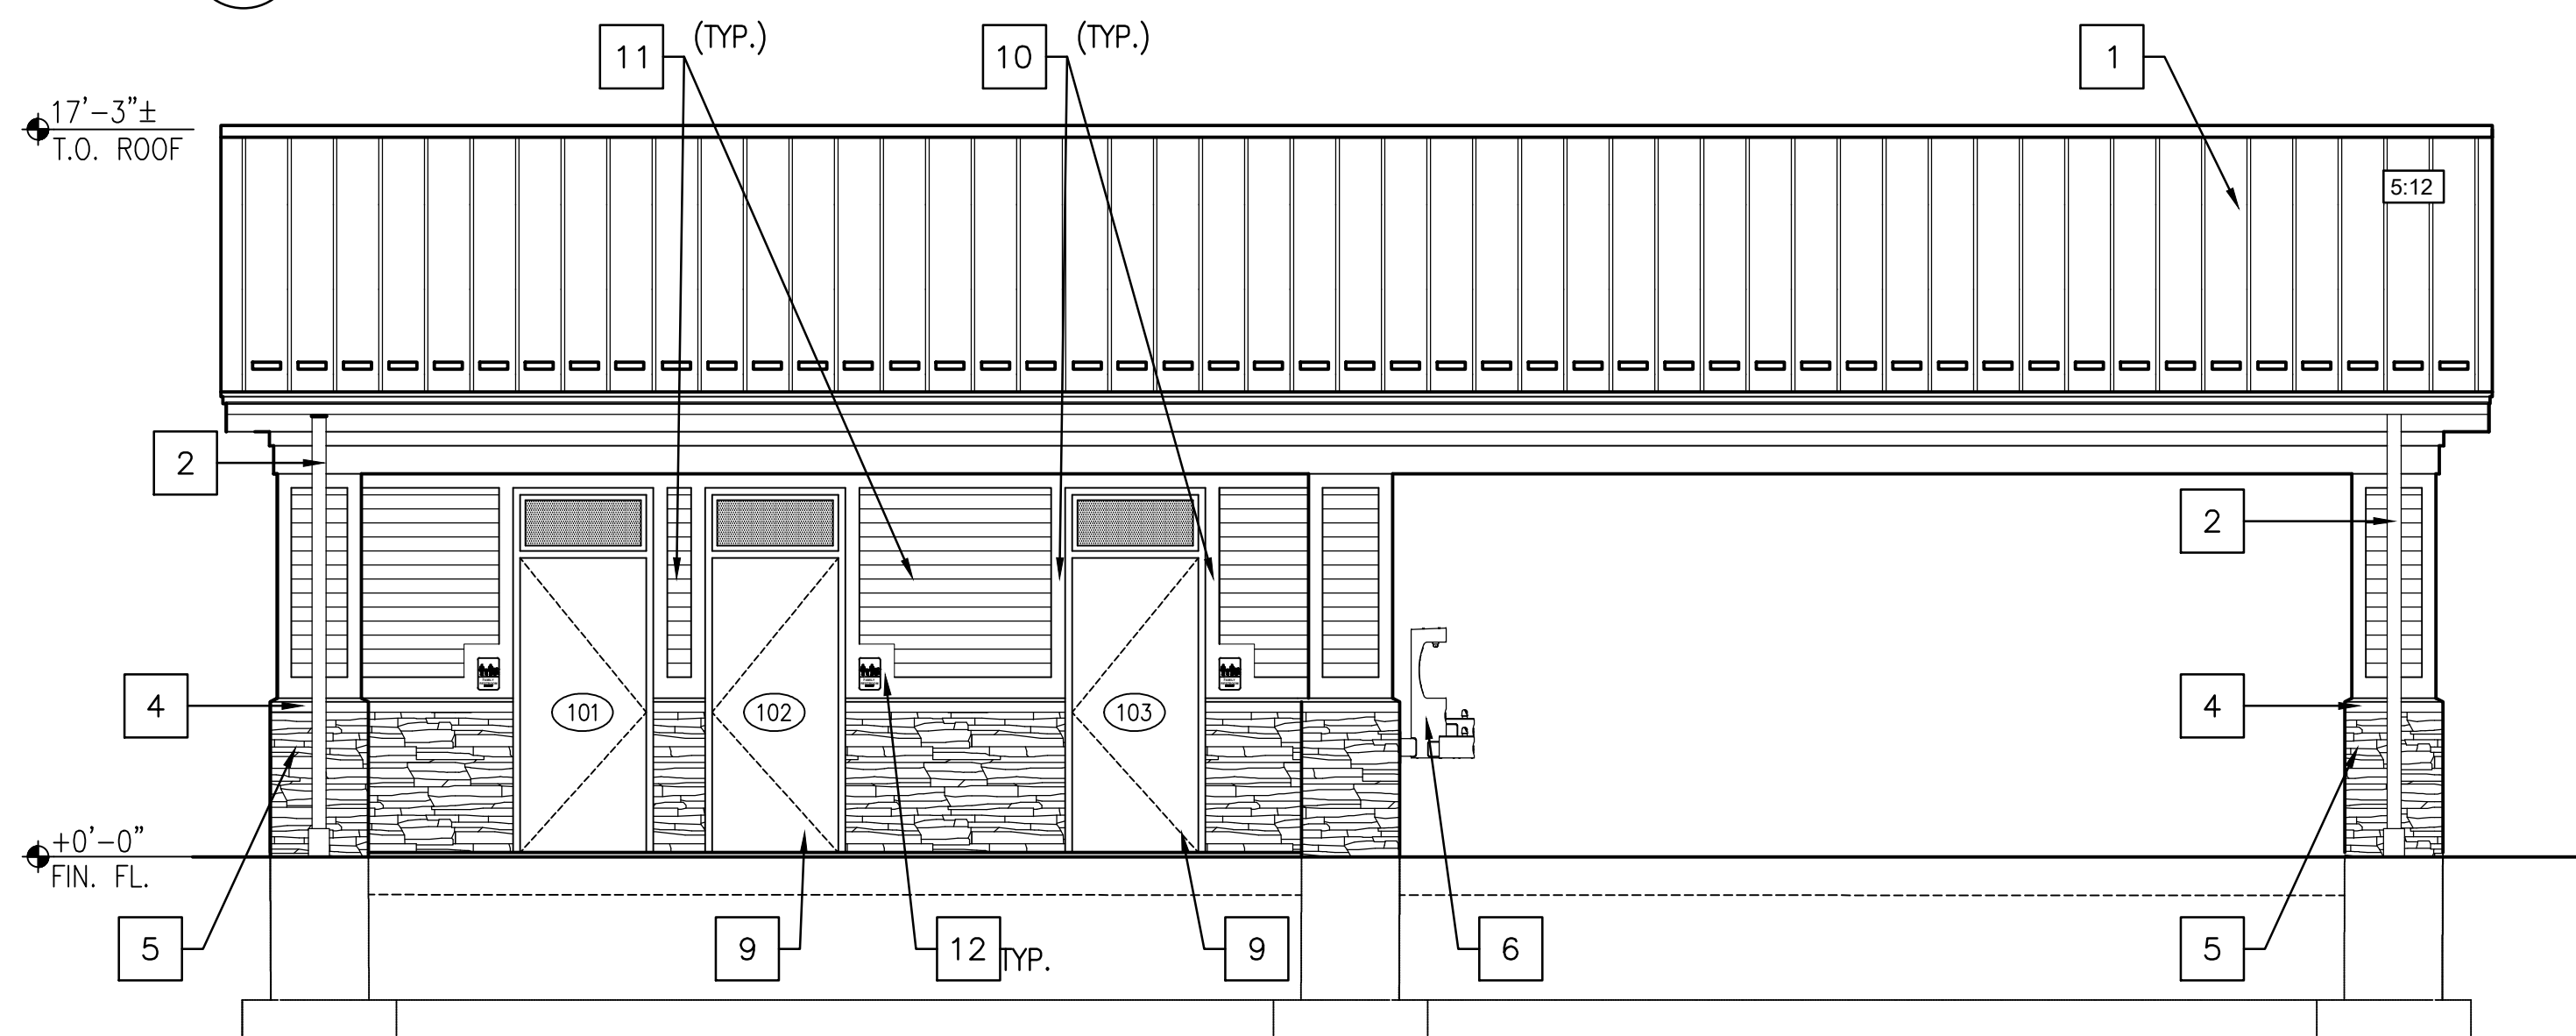

B1 ELEVATION
SCALE: 1/4" = 1'-0"

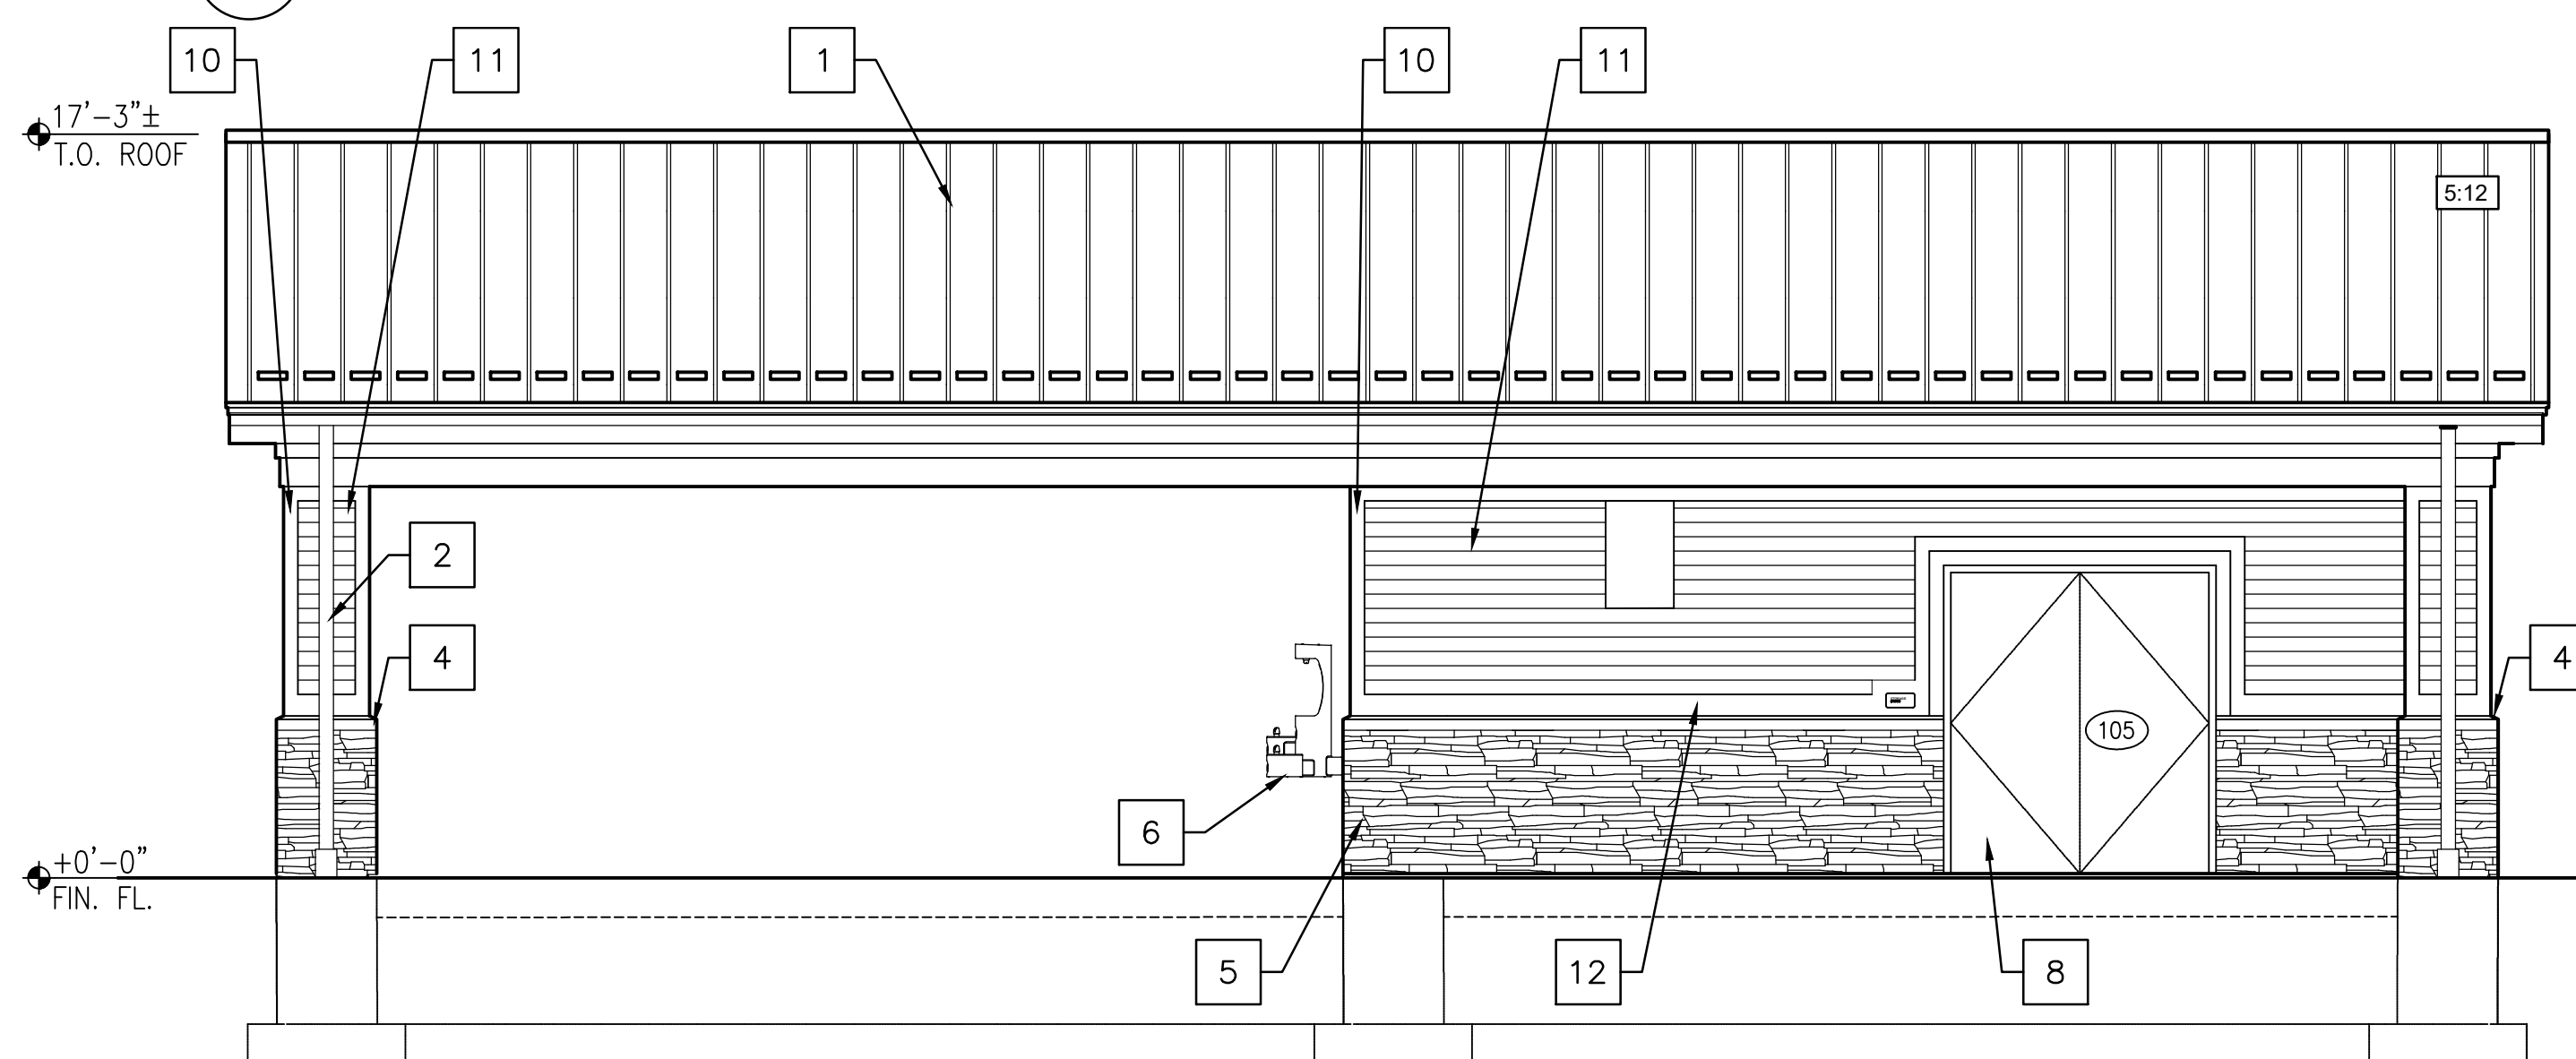

ELEVATION
SCALE: 1/4" = 1'-0"


KEY NOTES - ELEVATIONS

- 1 STANDING SEAM METAL ROOF
- 2 ALUMINUM GUTTER AND DOWNSPOUTS
- 3 FIBER CEMENT LAP SIDING 8" (FCS-1)
- 4 CAST STONE CAP
- 5 STONE VENEER
- 6 BI-LEVEL DRINKING FOUNTAIN W/ BOTTLE FILLER
- 7 FRESH AIR INTAKE LOUVER. COORDINATE EXACT LOCATIONS WITH MECHANICAL CONTRACTOR
- 8 PAINTED HOLLOW METAL STEEL FRAME AND DOOR
- 9 HOLLOW METAL FRAME W/ TRANSOM WINDOW
- REFER TO GLAZING TYPES THIS SHEET
- 10 FIBER CEMENT TRIM BOARD (FCT)
- 11 FIBER CEMENT LAP SIDING 4" EXPOSURE (FCS-2)
- 12 FIBER CEMENT PANEL (FCP)
AND 4" TRIM PERIMETER AT SIGNAGE
- 13 4" FIBER CEMENT TRIM (FCT) AROUND WALL VENT.

GLAZING TYPES



IG-1 - 1" INSULATED GLAZING W/ LOW E COATING
FROSTED GLASS

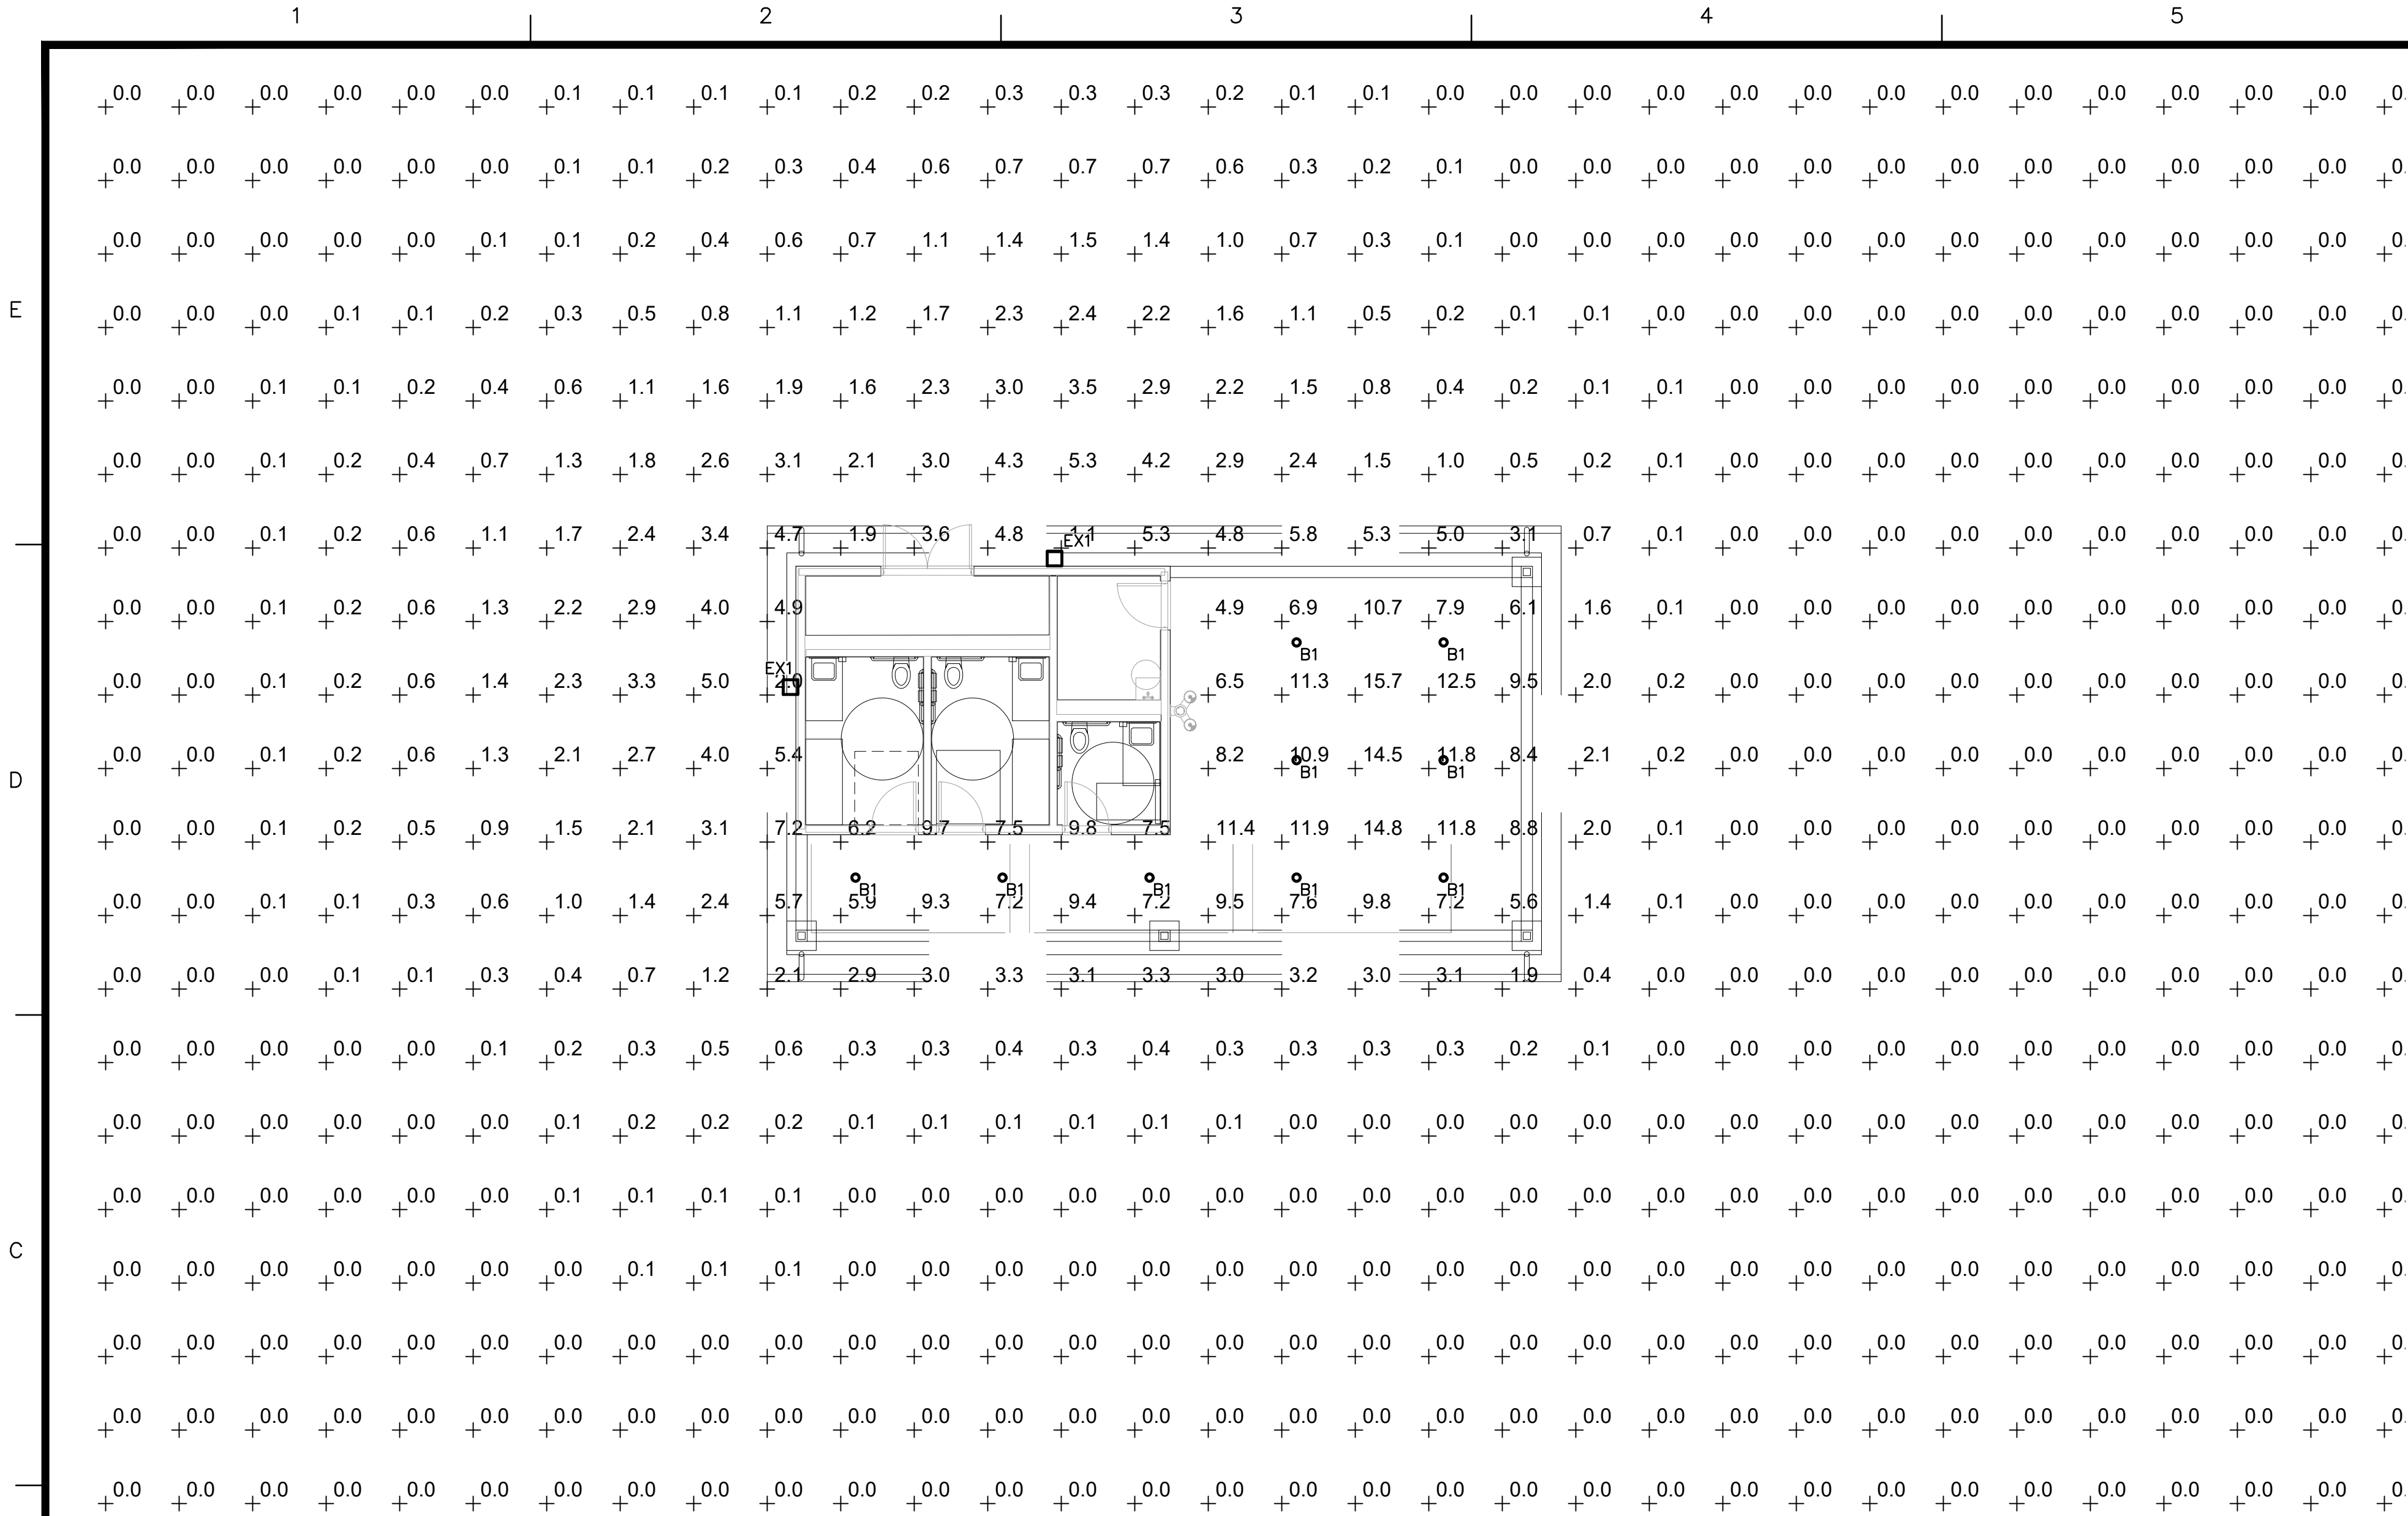

1 ELECTRICAL SITE PHOTOMETRIC PLAN
SCALE: 1/8" = 1'-0"

LIGHT FIXTURE SCHEDULE							
TYPE	DESCRIPTION	MOUNTING	LENS/DIFFUSER	VOLTAGE/ BALLAST	LAMPS (QUANTITY & TYPE)	MANUFACTURER & SERIES	NOTES/REMARKS
B1	RECESSED 6" LED DOWNLIGHT, EXTERIOR, WET LOCATION RATED AND IC RATED, AND ALUMINUM TRIM.	RECESSED	ALUMINUM REFLECTOR	UNV 120-277V 0-10V DIMMABLE DRIVER	10W, 1000 LUMENS, 3500°K LED SYSTEM	COOPER LIGHTING MOUNTING FRAME: #HC6-10-D010 LED MODULE: #HM6-0525-835 TRIM: #B1-MD-H	COORDINATE WITH ARCHITECTURAL REFLECTED CEILING PLAN AND PROVIDE TRIM KIT AS REQUIRED.
EX1	EXTERIOR WALL MOUNTED ARCHITECTURAL LED LIGHT FIXTURE. WET LOCATION LISTED. DARK SKY COMPLIANT.	SURFACE WALL	TYPE IV DISTRIBUTION OPTICS	UNV 120-277V 0-10V DIMMABLE DRIVER	30W, 3500 LUMENS, 3000°K LED SYSTEM	ANP LIGHTING #LA113-NL-CPS30W18-T4 -30K	PROVIDE ALL MOUNTING HARDWARE AS REQUIRED. MOUNTED AT 8'-0" ABOVE FINISHED FLOOR. COORDINATE FINAL MOUNTING HEIGHT WITH ARCHITECT/OWNER.

LIGHTING FIXTURE SCHEDULE NOTES

- CONTRACTOR SHALL VERIFY ALL FINAL FIXTURE COLORS WITH ARCHITECT PRIOR TO PURCHASING FIXTURES.
- CONTRACTOR SHALL PROVIDE LIGHTING FIXTURES THAT ARE LISTED, LABELED AND APPROVED BY UNDERWRITERS LABORATORIES INC. FOR USE WITH THE SPECIFIED CEILING TYPE AND RATING. COORDINATE WITH ARCHITECTURAL DRAWINGS, REFLECTED CEILING PLANS AND FILED VERIFICATION OF EXISTING CEILING TYPES AND CONDITIONS BY CONTRACTOR.
- CONTRACTOR SHALL PROVIDE ALL REQUIRED MOUNTING HARDWARE FOR A COMPLETE INSTALLATION.
- FOR ALL LIGHTING FIXTURES, PROVIDE TRIM KITS AS REQUIRED. COORDINATE EXACT REQUIREMENTS WITH ARCH. REFLECTED CEILING PLAN FOR GYP BOARD/GRID CEILING PLACEMENTS. FOR EXISTING CEILINGS FIELD VERIFY TYPES PRIOR TO PURCHASE.



2 TYPICAL WALL MOUNT INSTALLATION
SCALE: NONE

DiDonato Associates
Engineering and Architecture, P.C.

689 Main Street, Buffalo, NY 14203
t 716.656.1900 | f 716.656.1987
didonatoassociates.com

NOTE: UNAUTHORIZED ALTERATION OR ADDITION TO THIS DOCUMENT IS A VIOLATION OF SECTION 7209, PROVISION 2 OF THE NEW YORK STATE EDUCATION LAW.

BUFFALO ENGINEERING, P.C.
Mechanical - Electrical - Energy Engineers
4245 Union Road, Suite 204, Buffalo, NY 14225 | P 716 633 5300 | F 716 633 5598
WWW.BUFFALOEENGINEERING.COM



TOWN OF AMHERST

WILLOWDALE PARK
RESTROOM BUILDING

PUD Submission Only


MARK	DATE	DESCRIPTION
	7/24/2026	PUD SUBMISSION
ISSUE:		
PROJECT NO:		2025.024A
DESIGNER PROJECT NO:		26-3720
CAD DWG FILE:		ES-101.dwg
DRAWN BY:		EMW
CHECKED BY:		JEH
SCALE:		AS NOTED
COPYRIGHT:		

SHEET TITLE

ELECTRICAL SITE
PHOTOMETRIC PLAN

DRAWING#

ES-101

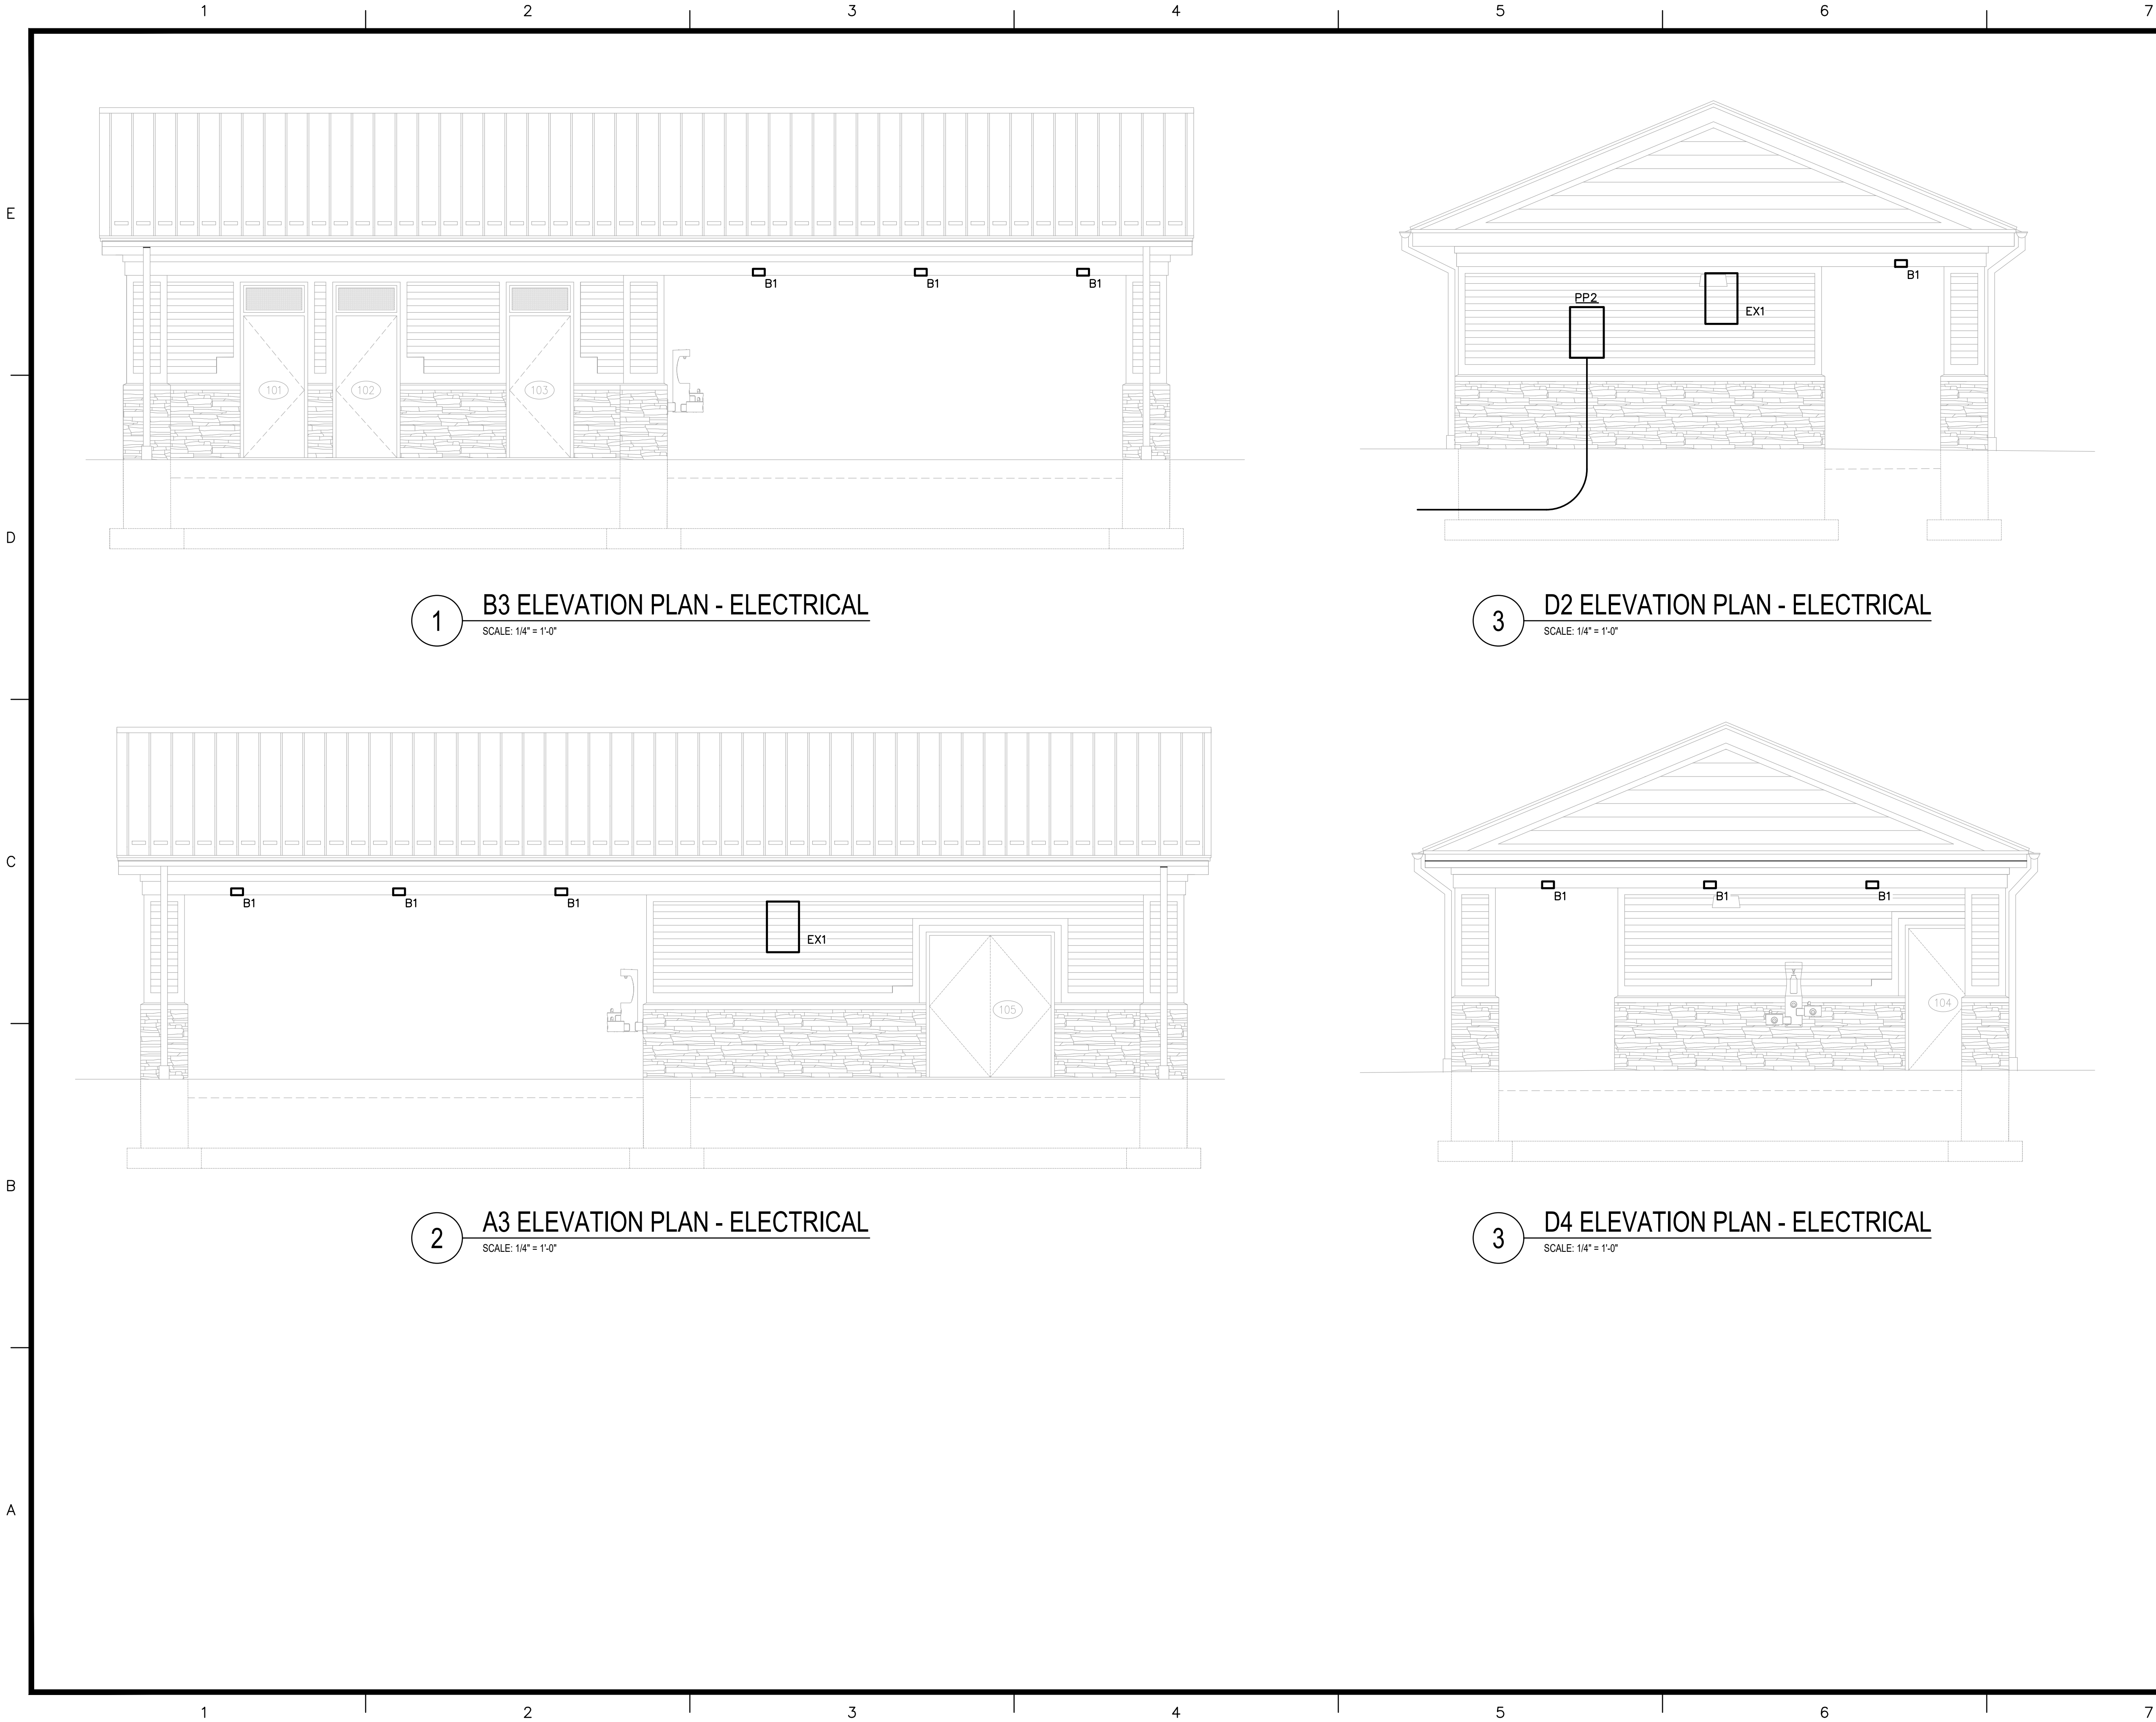

1 B3 ELEVATION PLAN - ELECTRICAL
SCALE: 1/4" = 1'-0"

3 D2 ELEVATION PLAN - ELECTRICAL
SCALE: 1/4" = 1'-0"

2 A3 ELEVATION PLAN - ELECTRICAL
SCALE: 1/4" = 1'-0"

3 D4 ELEVATION PLAN - ELECTRICAL
SCALE: 1/4" = 1'-0"



TOWN OF AMHERST
WILLOWDALE PARK
RESTROOM BUILDING

PUD Submission Only

	7/24/2026	PUD SUBMISSION
MARK	DATE	DESCRIPTION
ISSUE:		
PROJECT NO:		2025.024A
DESIGNER PROJECT NO:		26-3720
CAD DWG FILE:		ES-102.dwg
DRAWN BY:		EMW
CHECKED BY:		JEH
SCALE:		AS NOTED
COPYRIGHT:		

SHEET TITLE

ELEVATIONS -
ELECTRICAL

DRAWING#

ES-102