 




NOTE: BOUNDARY AND TOPOGRAPHIC INFORMATION PROVIDED BY OTHERS, CARMINA WOOD DESIGN ASSUMES NO RESPONSIBILITY FOR ITS ACCURACY.



Plant Schedule - Car Dealership, 6766 Tranist Road, Amherst, New York

KEY	QTY.	BOTANICAL NAME	COMMON NAME	MIN. SIZE	REMARKS
D E C I D U O U S T R E E S					
QRxB	7	Quercus robur x bicolor 'Long'	Regal Prince Oak	2 1/2" - 3" CAL.	B&B, HT. 40', W 18'
GT	6	Gleditsia triacanthos I "Draves"	Street Keeper Honey Locust	2 1/2" - 3" CAL.	B&B, HT. 40', W 35'
ARr	3	Acer rubrum 'Frank Jr.'	Redpointe Maple	Multi-stem, 12' tall min.	B&B, HT. 40', W 35'
QRn	3	Quercus robur x bicolor Nadler PP17604'	Kindred Spirit Oak	2 1/2" - 3" CAL.	B&B, HT. 30', W 6'
CBI	8	Carpinus betulus 'Lucas'	Lucas Columnar Hornbeam	2 1/2" - 3" CAL.	B&B, HT. 30', W 10'
ATxP	5	Acer truncatum x platanoides	Crimson Sunset Maple	2 1/2" - 3" CAL.	B&B, HT. 30', W 10'

S M A L L / O R N A M E N T A L T R E E S					
ALso	7	Amelanchier 'Standing Ovation'	Standing Ovation Serviceberry	1 1/2" x 2" CAL.	B&B, HT. 20', W 15'


AC	2	Abies concolor	White Fir	6-8' Tall	B&B, HT. 60', W 20'
PFv	5	Pinus flexilis 'Vanderwolfs'	Blue Limber Pine	6-8' Tall	B&B, HT. 20', W 8'
PAcu	9	Picea abies 'Cupressina'	Norway Spruce - Columnar	6-8' Tall	B&B, HT. 30', W 10'
JSmb	13	Juniperus scopulorum 'Moffat Blue'	Moffat Blue Juniper	6-8' Tall	B&B, HT. 16', W 3'

S H R U B S					
SCMp	8	Pinus mugo 'Sherwood Compact'	Sherwood Compact Mugo Pine	24" Tall (Max. Hght 24")	B&B, HT. 2', W 3'
IGgb	19	Ilex glabra 'Gem Box'	Inkberry Holly - Gem Box	24-36" Tall	B&B, HT. 4', W 4'
AFR	15	Cornus stolonifera/C sericea 'Farrow'	Arctic Fire Red Twig Dogwood	24-36" Tall	B&B, HT. 4', W 4'
RRr	6	Rosa radrazz	Knockout Rose	18-24" Tall	Cont. no.3 - 3" Tall, 3" Wide
VC	20	Viburnum carlesii	Viburnum Carlesii	36-48" Tall	B&B, HT. 5', W 6'
WF	23	Weigela florida 'Wine and Roses'	Wine and Roses Weigela	36-48" Tall	B&B, HT. 4', W 5'
PMp	12	Pinus mugo 'Pumilio'	Dwarf Mugo Pine	24-36" Tall	B&B, HT. 4', W 6'
IxMH	8	Ilex x meserveae 'Hachfee'	Castle Spire Blue Holly	24-36" Tall	B&B, HT. 10', W 4'

G R A S S E S / P E R E N N I A L S / G R O U N D C O V E R S					
RO	8	Andropogon Gerardii	Big Blue Stem Andropogon	18-24" Tall	Cont. #3, HT. 4', W 6'
LM	12	Liriope muscari	Big Blue Lilyturf	12-16" Tall	Cont. no.3 - 3" Tall, 3" Wide
NxF	31	Nepeta x faassenii	Walkers Low Catmint	6-12" Tall	Cont. no.3 - 18" Tall, 1-4" Wide
KF	26	Calamagrostis x acutiflora	Karl Foerster Reed Grass	18-24" Tall	Cont. no.3 - 3" Tall, 3" Wide
MS	6	Miscanthus sinensis 'Adagio'	Adagio Maiden Grass	18-24" Tall	Cont. no.3 - 5" Tall, 3" Wide

Plant schedule represents total counts for proposed plantings - including any foundation plantings @ all proposed structures

The required screening of any structure relating to site utilities, refuse containment, etc. will be screened according to the applicable section of amherst town code - Chapter 203 - Section 7 as it pertains to the landscape plan. it is responsibility of contractor to allow for any additional plantings for structures relating to mechanical equipment which may not be shown on plan. Coordination with MEP Engineer(s) may be required.

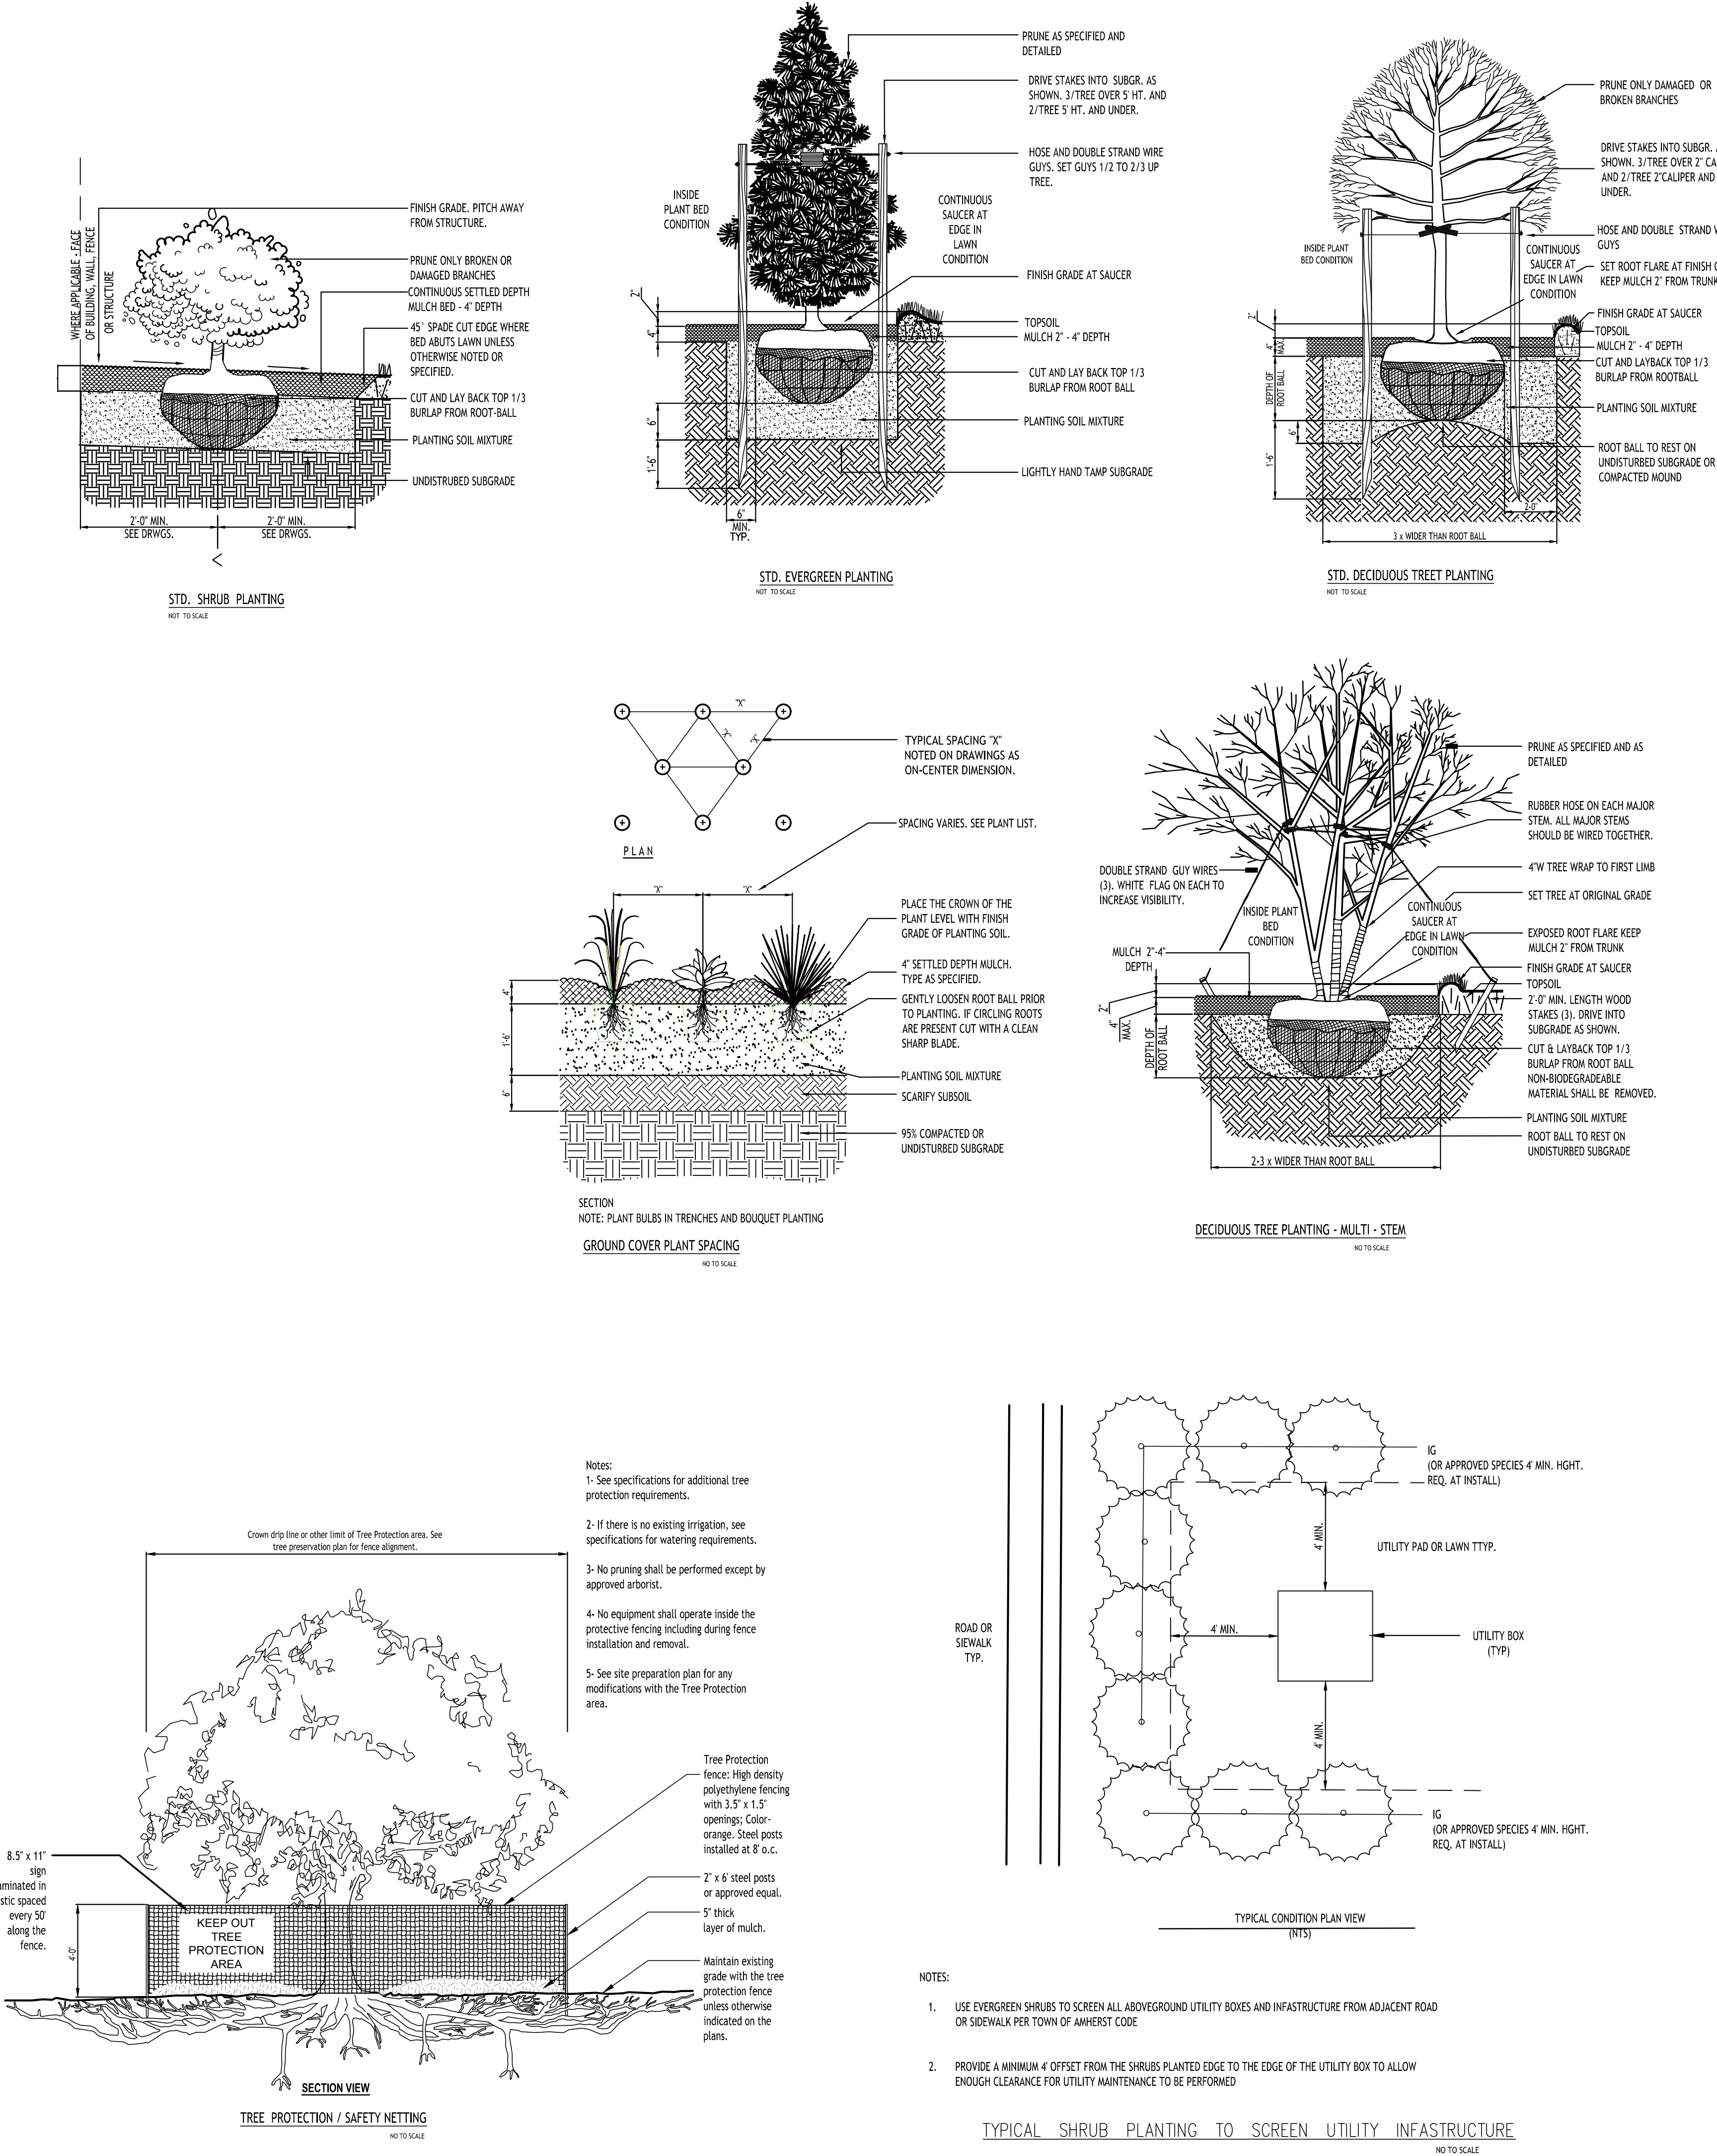

REVISIONS:	No.	Description	Date



DRAWING NAME:
Site Details
Plant Schedule

Date: 8/27/26
Drawn By: A. Pandolfi
Scale: As Noted


DRAWING NO.

C-101

Project No: 26-4120

All Rights Reserved. Reuse of these documents without the expressed written permission of CARMINA WOOD DESIGN is prohibited. WARNING: It is a violation of article 145 of the New York State Education Law for any person to alter this drawing, if altered such R.A., P.E. or L.L.S. shall affix his or her signature, the date the notation "Altered By" and a specific description of the alteration.

© CARMINA WOOD DESIGN

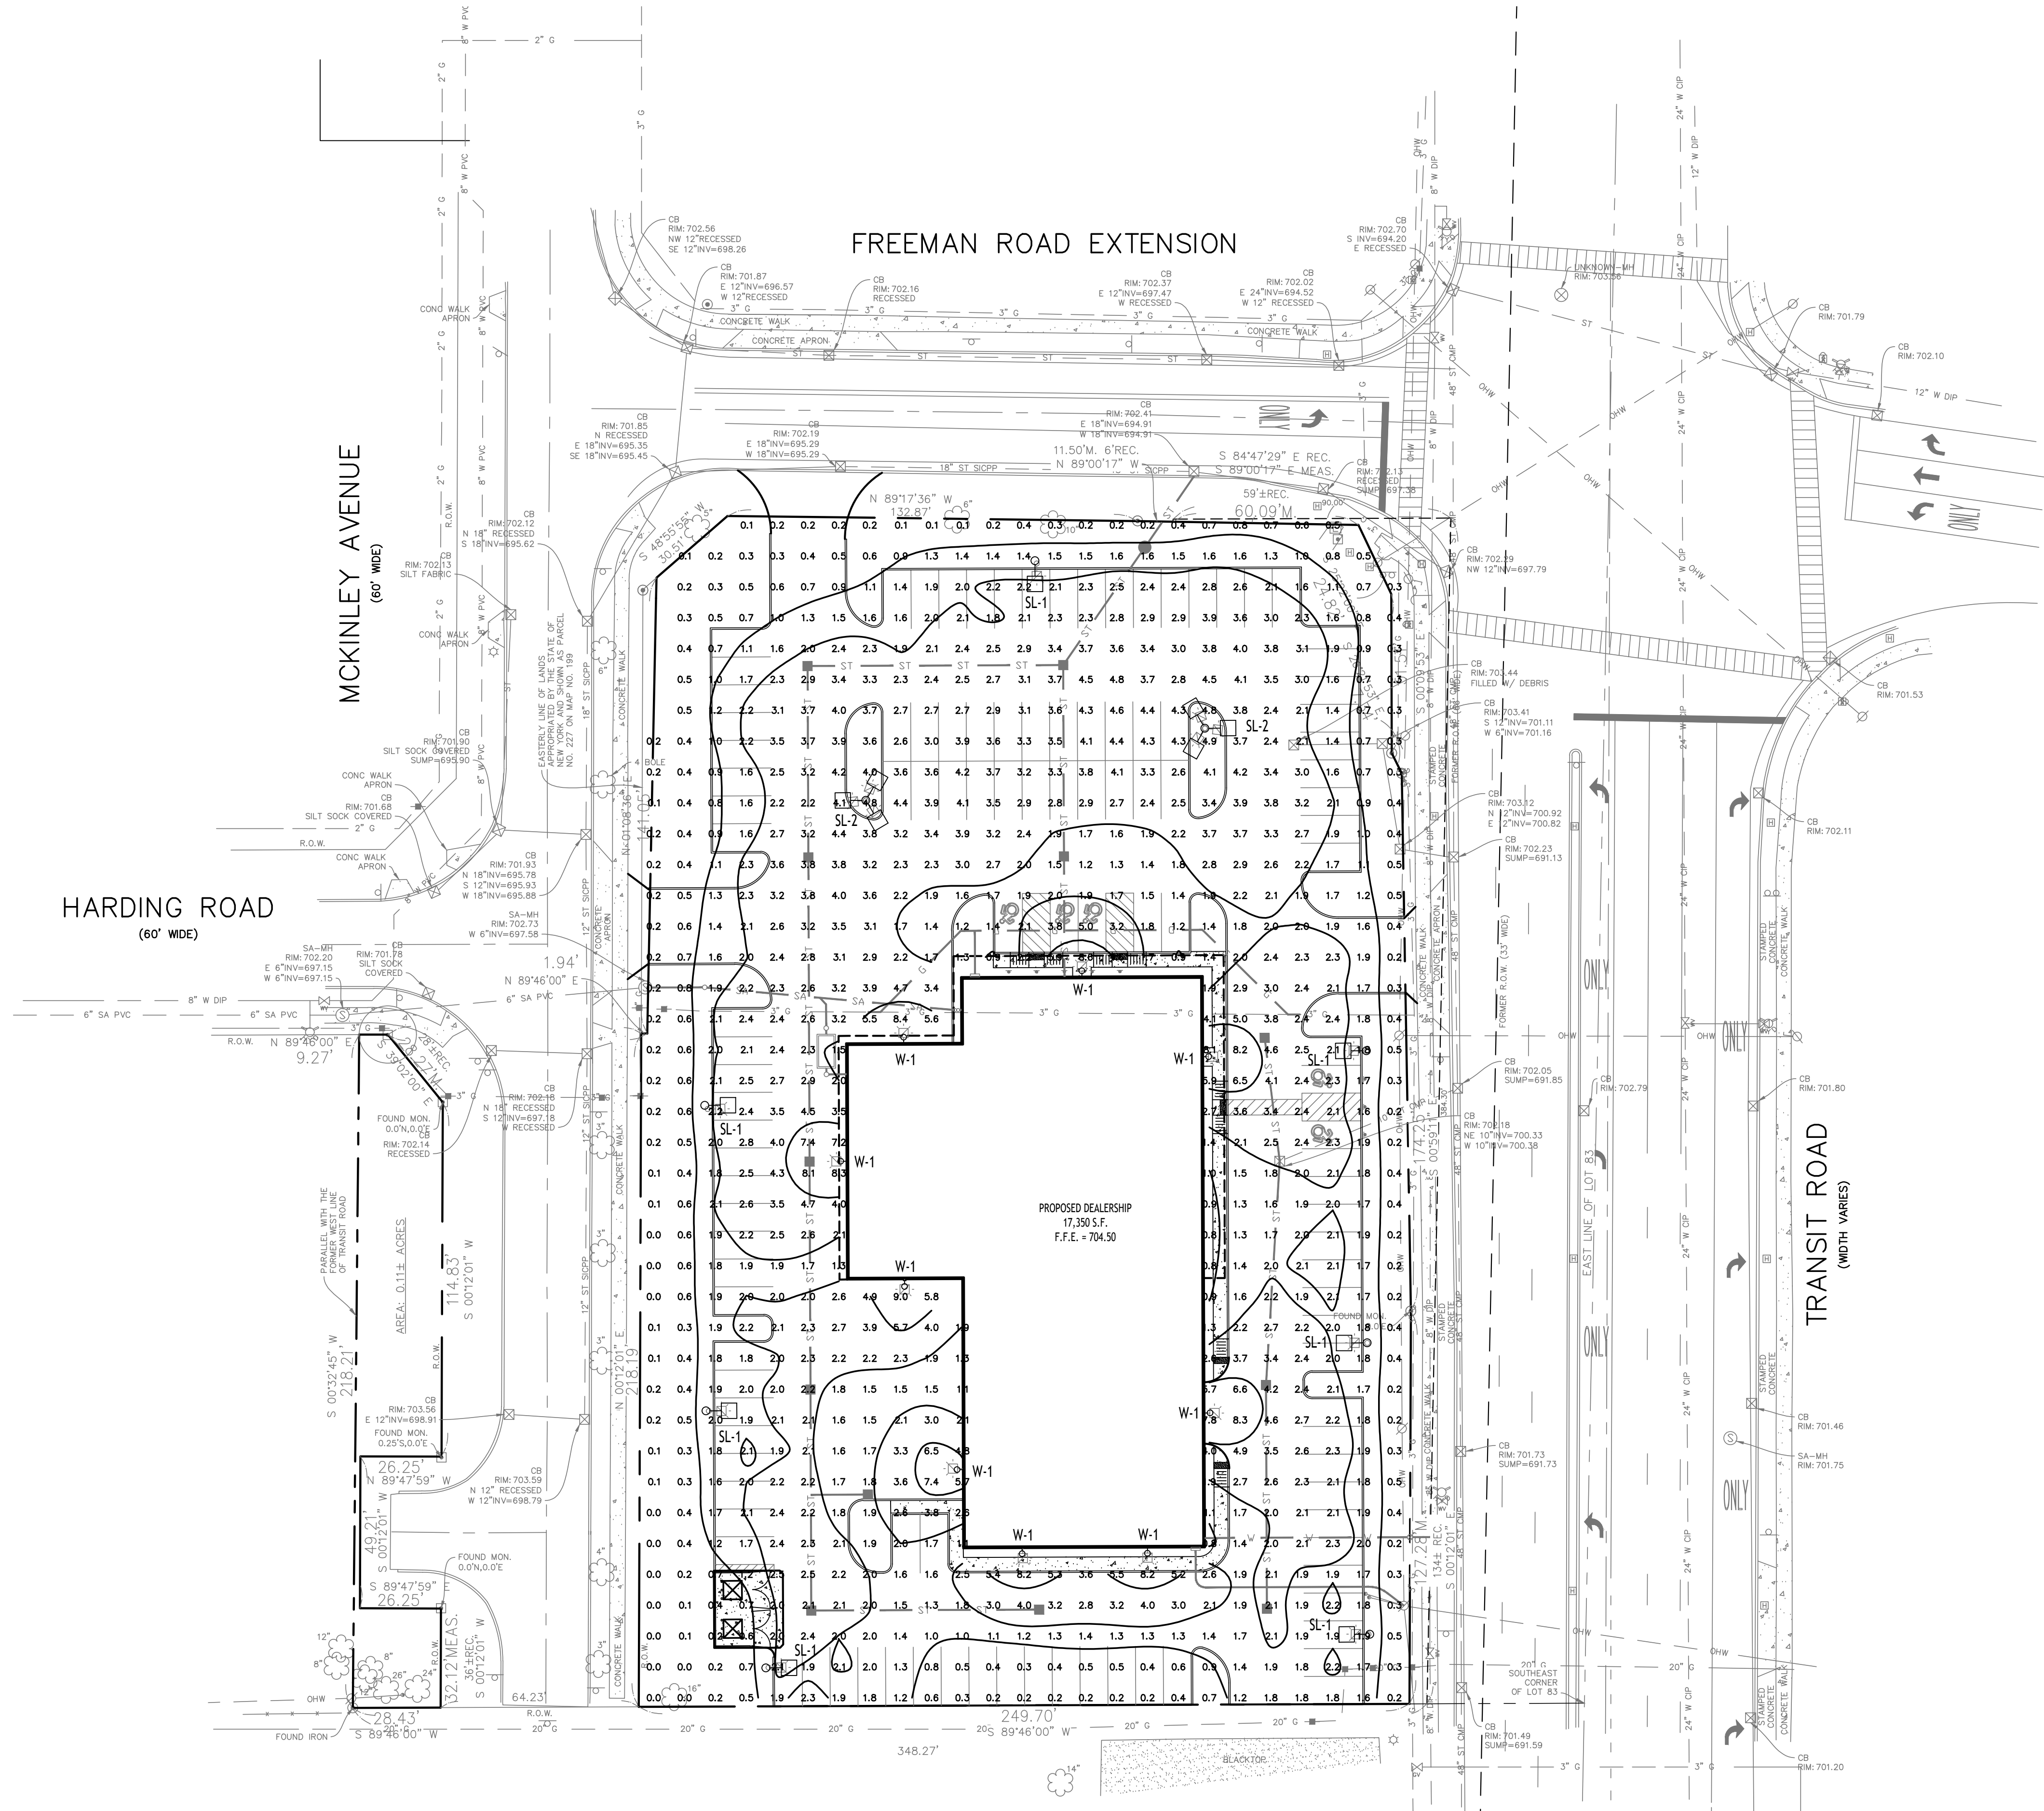

SITE LEGEND

- PROPERTY LINE
- PROPOSED CONCRETE CURB
- PROPOSED SIDEWALK / CONCRETE PAD
- NUMBER OF PARKING SPACES
- PROPOSED SIGN
- PROPOSED STANDARD DUTY ASPHALT PAVEMENT
- PROPOSED LIGHT POLE
- PROPOSED WALL MOUNTED LIGHT

NOTE: BOUNDARY AND TOPOGRAPHIC INFORMATION PROVIDED BY OTHERS. CARMINA WOOD DESIGN ASSUMES NO RESPONSIBILITY FOR ITS ACCURACY.



LIGHTING PLAN

SCALE: 1"=30'

LUMINAIRE SCHEDULE										
CALLOUT	SYMBOL	LAMP	DESCRIPTION	BALLAST	MOUNTING	MODEL	VOLTS	NOTE 1	NOTE 2	QUANTITY
SL-1		(32)	GALLEON AREA AND ROADWAY LUMINAIRE(2) 70 CRI, 4000K, 1050mA LIGHTSQUARES WITH 16 LEDS EACH AND TYPE IV WIDE OPTICS WITH HOUSE SIDE SHIELD	ELECTRONIC	POLE	COOPER LIGHTING SOLUTIONS - MCGRAW-EDISON GAIN-SA2C-740-U-T4W-HSS	120V 1P 2W	Mounting Height: 25.0'	BUG Rating: B2-U0-G2	7
SL-2		(32)	GALLEON AREA AND ROADWAY LUMINAIRE(2) 70 CRI, 4000K, 1050mA LIGHTSQUARES WITH 16 LEDS EACH AND TYPE IV WIDE OPTICS WITH HOUSE SIDE SHIELD	ELECTRONIC	POLE	COOPER LIGHTING SOLUTIONS - MCGRAW-EDISON GAIN-SA2C-740-U-T4W-HSS	120V 1P 2W	Mounting Height: 25.0'	BUG Rating: B2-U0-G2	2
W-1		(20) (20) 2200K CCT, 70 CRI LEDS	SEKKO WALL PACK 8000LM PACKAGE 700CRI 2200K FIXTURE w/ TYPE IV WIDE DISTRIBUTION OPTIC	ELECTRONIC	WALL	COOPER LIGHTING SOLUTIONS - MCGRAW-EDISON GKO-PB2C-722-U-T4W	120V 1P 2W	Mounting Height: 12.0'	BUG Rating: B1-U0-G2	9

GENERAL PHOTOMETRIC SCHEDULE

AVERAGE FOOT-CANDLES	2.10
MAXIMUM FOOT-CANDLES	9.0
MINIMUM FOOT-CANDLES	0.2

CARMINA WOOD

DESIGN

Buffalo | Utica | Greensboro

Car Dealership

6766 Transit Road
Amherst, New York

REVISIONS:

No. Description

Date



DRAWING NAME:

Lighting Plan

Date: 8/27/26
Drawn By: A. Pandolfe
Scale: As Noted

DRAWING NO.

LP-100

Project No: 26-4120

